


FOUNDATION PLAN
 1/8"=1'-0"
 PLAN

GENERAL FOUNDATION NOTES:


- ALL COLUMN FOOTINGS ARE CENTERED ON COLUMNS AND WALL FOOTINGS ARE CENTERED BENEATH WALL U.N.O.
- FOR GENERAL STRUCTURAL NOTES AND SPECIFICATIONS SEE ST.
- STEPPED WALL FOOTINGS ARE INDICATED THUS:
 TFE-S TFE=96'-8" AT EXTERIOR U.N.O.
 SEE 2/S4 FOR STANDARD DETAIL.
 CONTRACTOR SHALL EITHER STEP FOOTINGS FROM EXTERIOR FOOTING ELEVATION TO INTERIOR FOOTING ELEVATION OR INSTALL 8"x24" CMU PIER SOLID GROUTED.
- SEE ARCHITECTURAL PLANS FOR LOCATIONS OF RECESSED SLABS, SLOPED AREAS IN SLABS ON GRADE, AND CURBS.
- VERIFY ALL OPENINGS AND DIMENSIONS WITH ARCHITECTURAL DRAWINGS.
- INSTALL FOUNDATION DRAIN TILE PER RECOMMENDATIONS OF SOILS REPORT AND AS INDICATED ON ARCHITECTURAL SECTIONS.
- COORDINATE LOCATION OF STEPPED FOOTINGS WITH CIVIL DOCUMENTS, MAINTAIN MINIMUM FROST COVER OF 3'-6" AT BUILDING FOUNDATIONS AND 5'-0" AT FOOTINGS AWAY FROM BUILDING. VERIFY COVER REQUIREMENTS WITH GEOTECHNICAL REPORT.



STUDIO 22517 17th Ave. Suite 200
 Cold Spring, Minnesota 56320
 TELEPHONE 320.685.3304
 FACSIMILE 320.685.4039

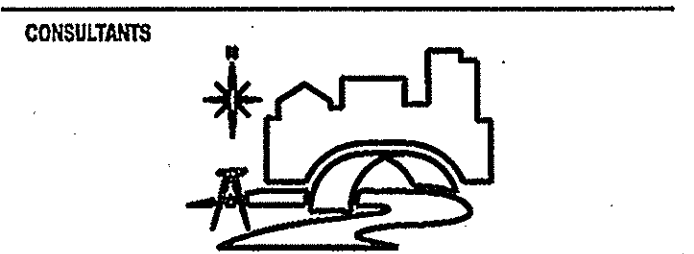

DUFFY ENGINEERING AND ASSOCIATES, INC.
 STRUCTURAL - CIVIL - SURVEYING -
 MECHANICAL - ELECTRICAL
 350 Highway 10 South Suite 101 St.
 Cloud, MN 56304
 Phone (320) 259-6575
 Fax: (320) 259-6991
 Email: mail@duffyeng.com

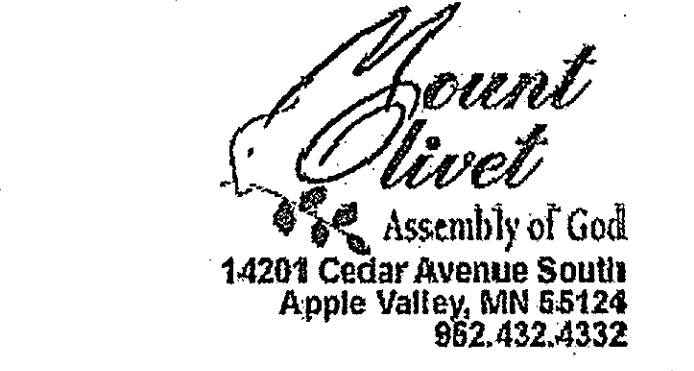

14201 Cedar Avenue South
 Apple Valley, MN 55124
 952.432.4332

PIER SCHEDULE		
MK	SIZE	REINFORCING
P1	16"x16"	4-#6 VERT & #3 TIES AT 12" OC
P2	24"x24"	8-#6 VERT & #3 TIES AT 12" OC
P3	24"x32"	8-#6 VERT & #3 TIES AT 12" OC

FOOTING SCHEDULE		
MK	SIZE	REINFORCING
F1	1'-4"x1'-0"	2-#5 CONT
F1A	1'-4"x1'-0"	2-#7 CONT
F2	1'-0"x0'-8"	2-#7 CONT
F3	2'-0"x1'-0"	2-#5 CONT
F4	3'-6"x3'-6"x1'-0"	3-#5 EW
F5	4'-0"x4'-0"x1'-0"	4-#5 EW
F6	5'-0"x5'-0"x1'-0"	5-#5 EW
F7	6'-6"x6'-6"x1'-0"	6-#5 EW
F8	7'-6"x7'-6"x1'-4"	7-#5 EW
F9	FIREPLACE FTG FIELD VERIFY SIZE W/ SER	#5@12" OC T&B

I hereby certify that this plan, specification or report was prepared by me or under my direct supervision and that I am a duly Licensed Engineer under the laws of the state of Minnesota.

RYAN J. SEAVERT, PE
 Date: 02-13-07 License No. 41971

FOUNDATION PLAN

PROJECT NO: 06337
 SCALE: 1/8"=1'-0"
 DATE: 02-13-07
 DRAWN BY: JKJ
 DRAWN BY: RJS